

PROJECT:

South Jersey
Health & Wellness
1919 Greentree Road
CHERRY HILL, NJ

TITLE: Plan
Date Drawn: 10/22/08


Drawn By/Checked By:
x / x

Date:

PHASE:

- Existing Conditions
- Predesign Service
- Schematic Design
- Design Development
- Bid Document
- Construction Documents
- Supplemental Information
-

Project #: 1728

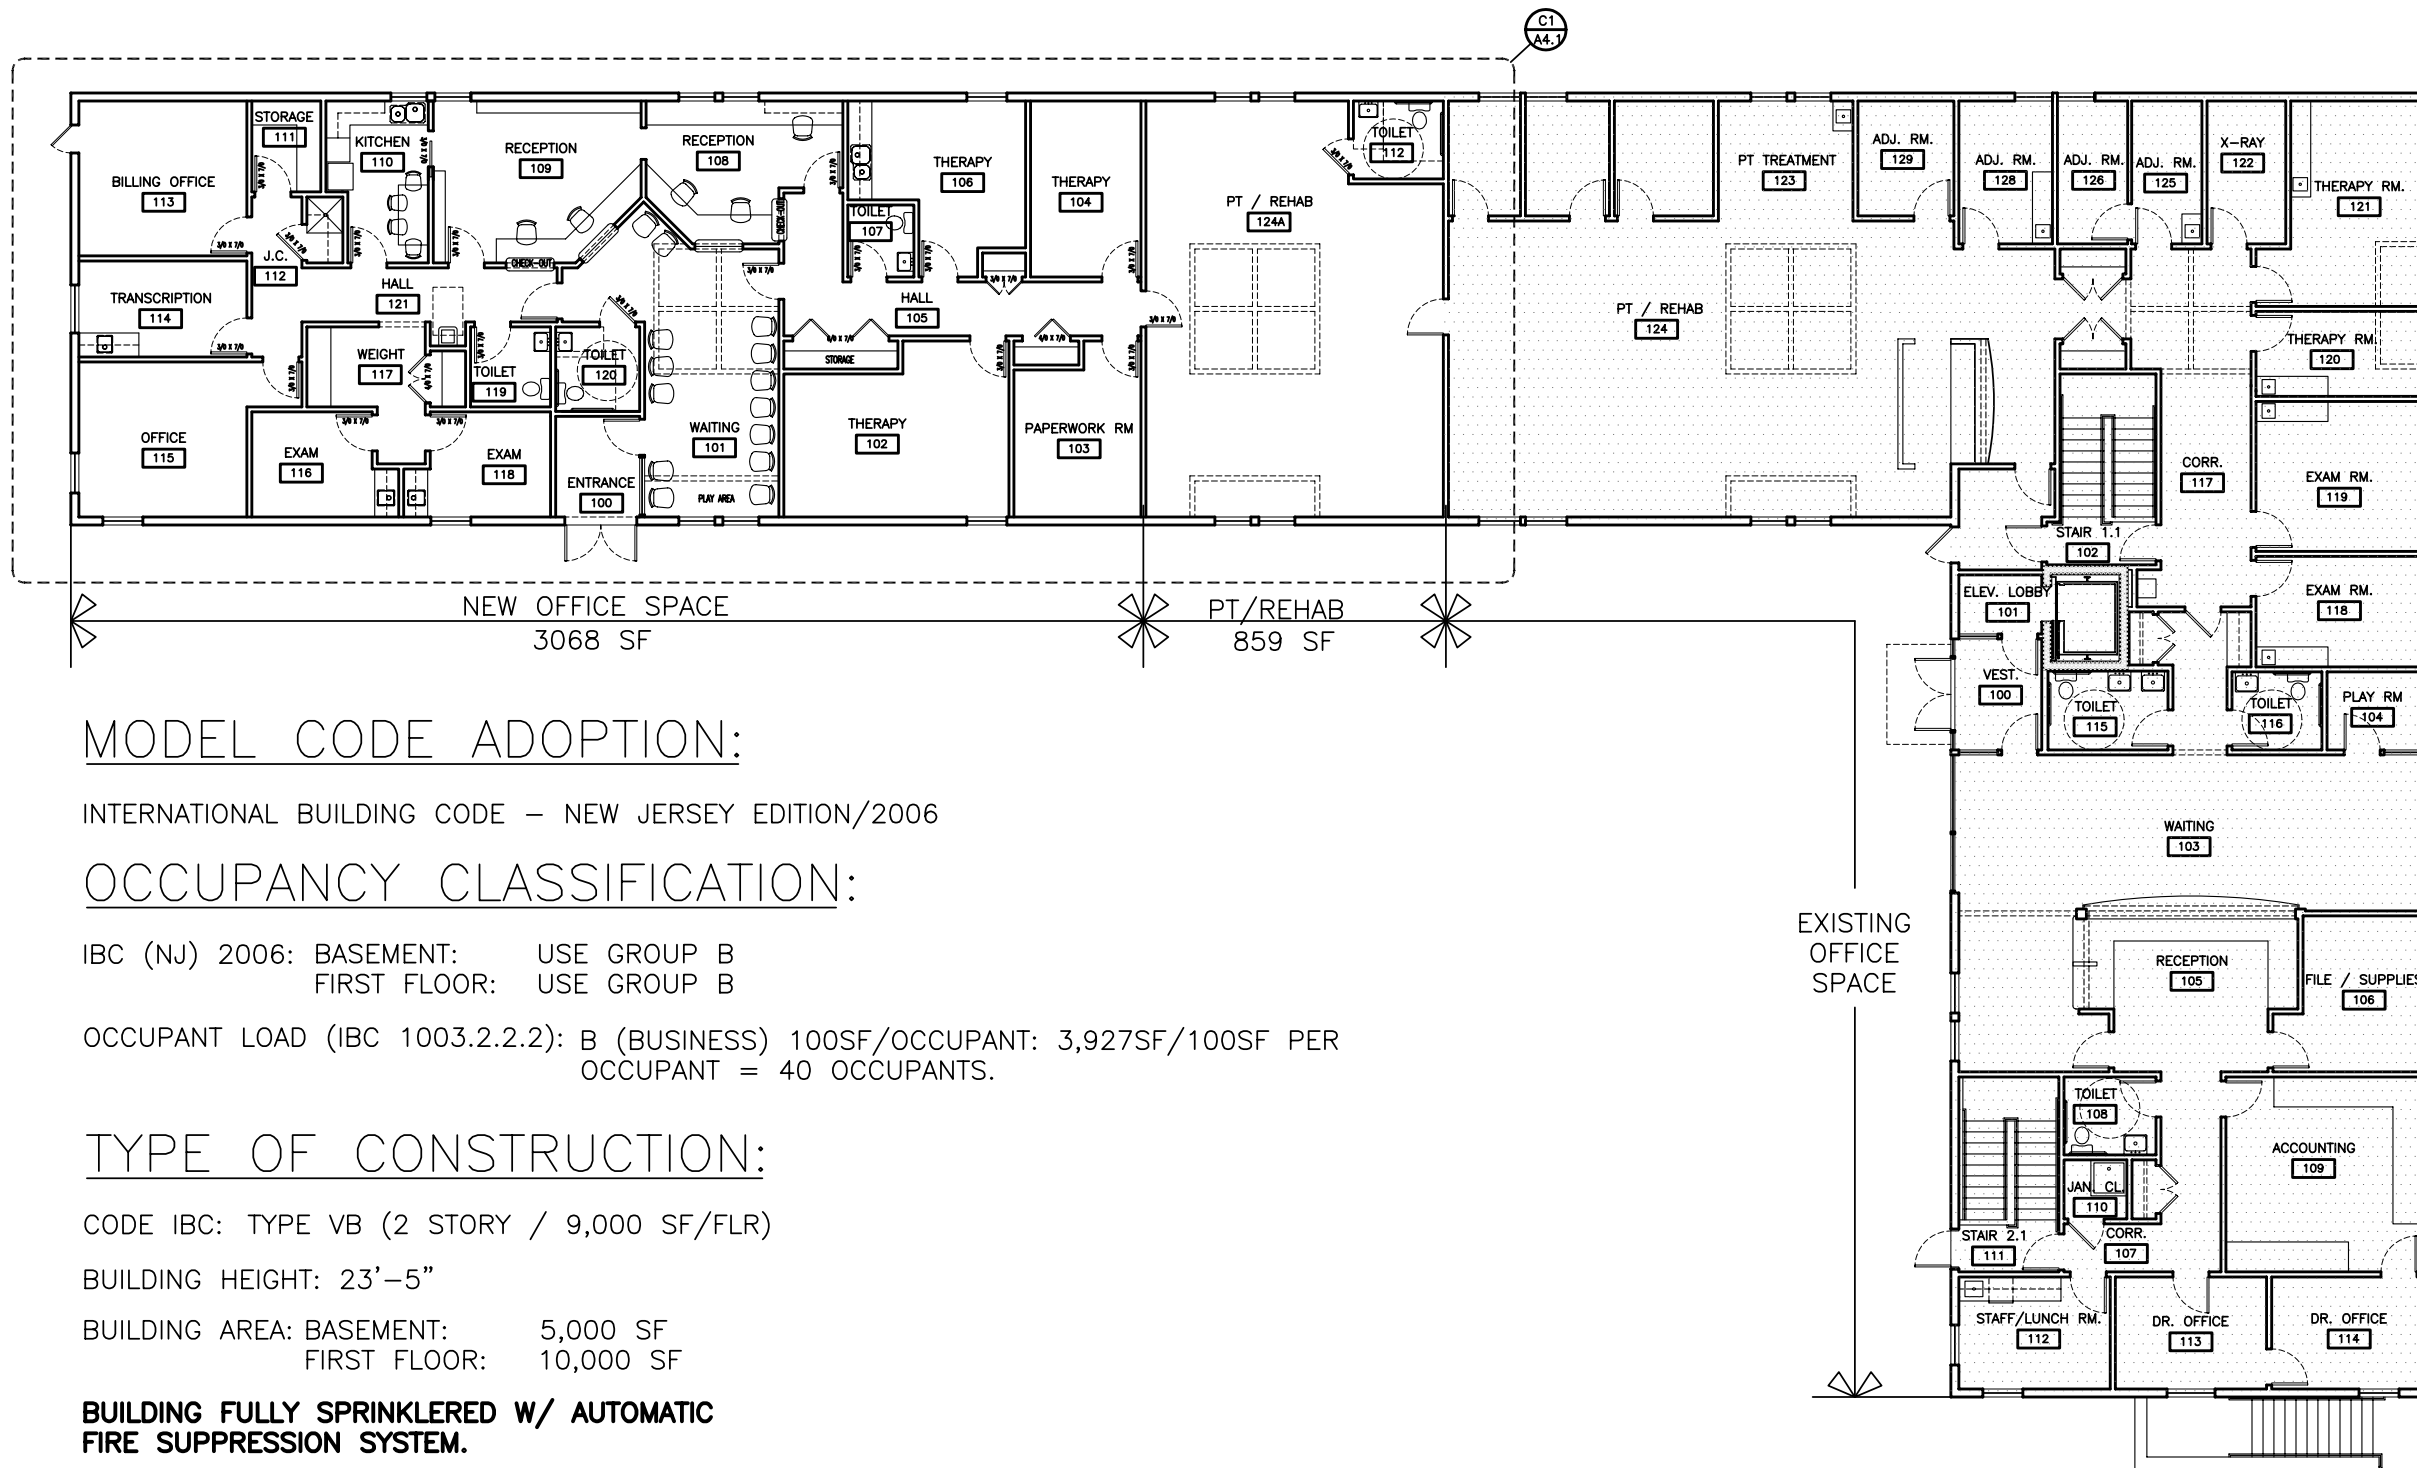

MODEL CODE ADOPTION:

INTERNATIONAL BUILDING CODE – NEW JERSEY EDITION/2006

OCCUPANCY CLASSIFICATION:

IBC (NJ) 2006: BASEMENT: USE GROUP B
FIRST FLOOR: USE GROUP B

OCCUPANT LOAD (IBC 1003.2.2.2): B (BUSINESS) 100SF/OCCUPANT: 3,927SF/100SF PER OCCUPANT = 40 OCCUPANTS.

TYPE OF CONSTRUCTION:

CODE IBC: TYPE VB (2 STORY / 9,000 SF/FLR)

BUILDING HEIGHT: 23'-5"

BUILDING AREA: BASEMENT: 5,000 SF
FIRST FLOOR: 10,000 SF

BUILDING FULLY SPRINKLERED W/ AUTOMATIC FIRE SUPPRESSION SYSTEM.

AREA MODIFICATIONS (IBC 506.3): AUTOMATIC SPRINKLER INCREASE
9000 SF X 200% = 18,000 SF > 10,000 SF

1 FIRST FLOOR KEY PLAN
SCALE: 1/16" = 1'-0"

10,000 SF

©All reproduction rights reserved. Reproduction without written permission is prohibited.

PROJECT:

South Jersey
Health & Wellness
1919 Greentree Road
CHERRY HILL, NJ


TITLE: Plan
Date Drawn: 10/22/08

Drawn By/Checked By
/


Date:

- PHASE:
- Existing Conditions
 - Predesign Service
 - Schematic Design
 - Design Development
 - Bid Document
 - Construction Documents
 - Supplemental Information

Project #: 1728

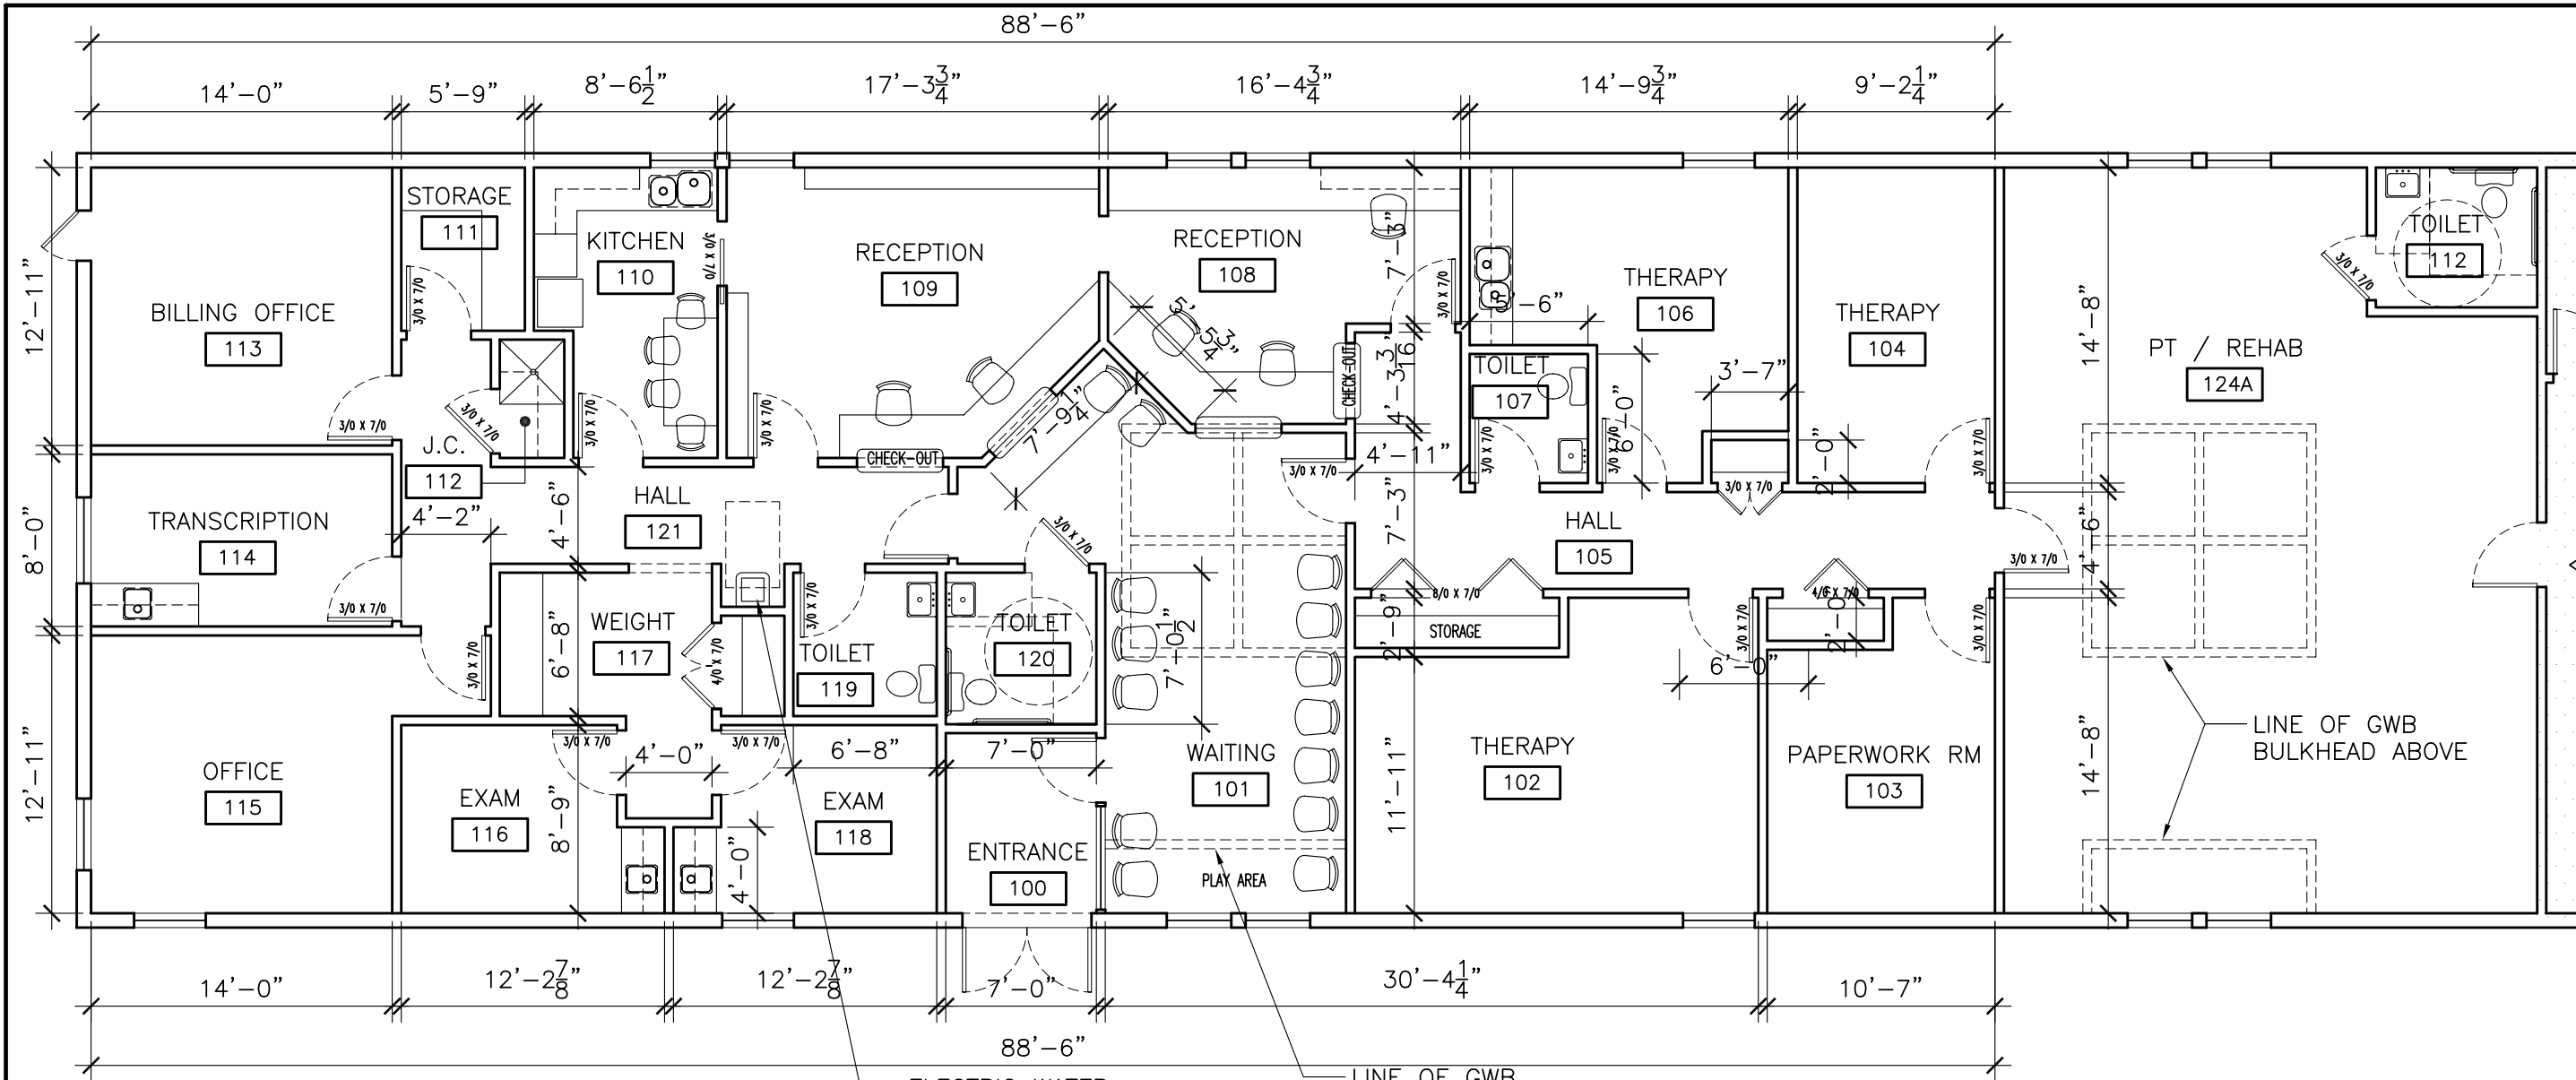

1 FLOOR PLAN
SCALE: 1/8" = 1'-0"

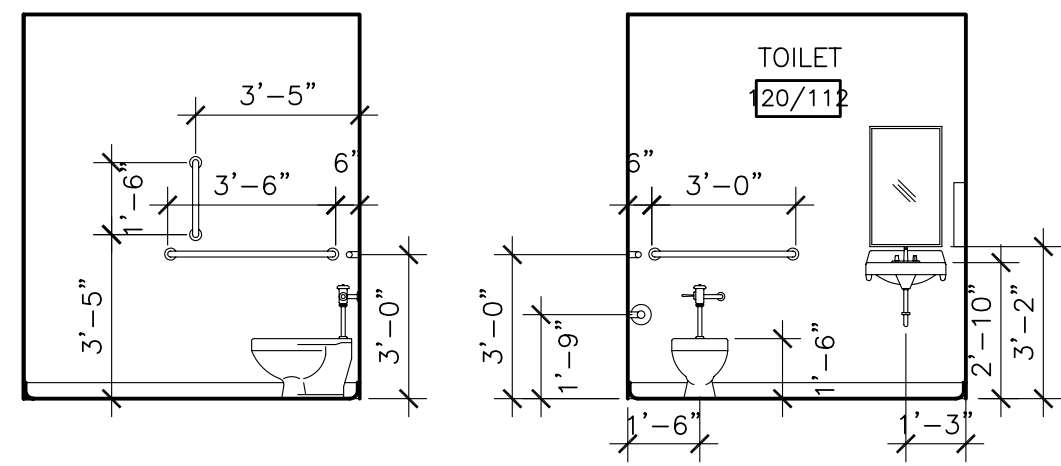

2 TOILET ROOM ELEVATIONS
SCALE: 1/4" = 1'-0"

PROJECT:

South Jersey
Health & Wellness
1919 Greentree Road
CHERRY HILL, NJ

TITLE: Plan

Date Drawn: 7/30/08

Drawn By/Checked By

x / x

Date:


PHASE:

- Existing Conditions
- Pre-design Service
- Schematic Design
- Design Development
- Bid Document
- Construction Documents
- Supplemental Information

Project #: 1728




 


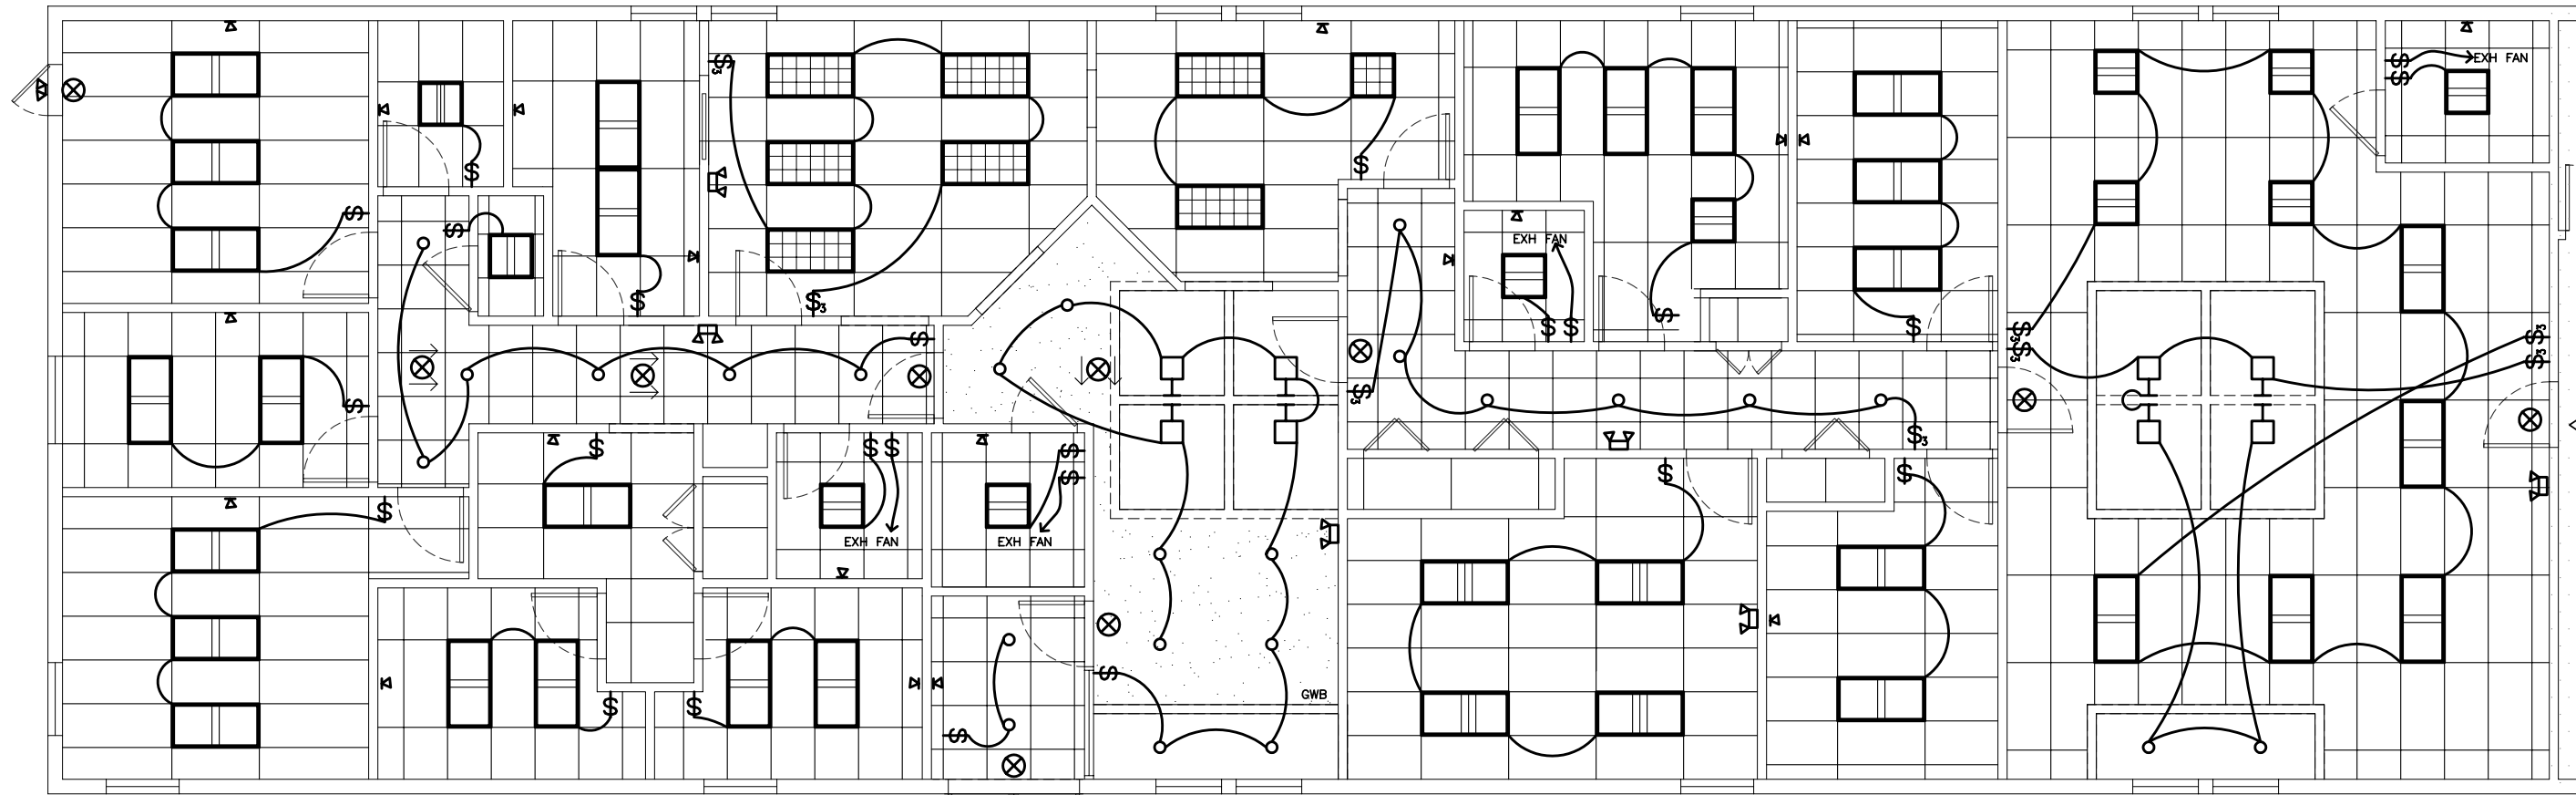
 
 
 
 
 
DEL. 1

OF



1 LIGHTING FLOOR PLAN
SCALE: 1/8" = 1'-0"

LIGHTING SYMBOLS

-  2X2 FLUORESCENT
-  2X4 FLUORESCENT
-  2X4 TROFFER
-  2X2 TROFFER
-  SURFACE MOUNTED FIXTURE
-  RECESSED PERIMETER FLUORESCENT
-  FLUORESCENT DOWN LIGHT
-  SURFACE MOUNTED FIXTURE
-  EMERGENCY LIGHT
-  DUAL HEAD EMERGENCY LIGHT
-  SINGLE HEAD EMERGENCY LIGHT
-  EMERGENCY EXIT SIGN

©All reproduction
rights reserved.
Reproduction without
written permission
is prohibited.

PROJECT:

South Jersey
Health & Wellness
1919 Greentree Road
CHERRY HILL, NJ

TITLE: Plan

Date Drawn: 7/30/08

Drawn By/Checked By


x / x

Date:

PHASE:

- Existing Conditions
- Pre-design Service
- Schematic Design
- Design Development
- Bid Document
- Construction Documents
- Supplemental Information
-

Project #: 1728

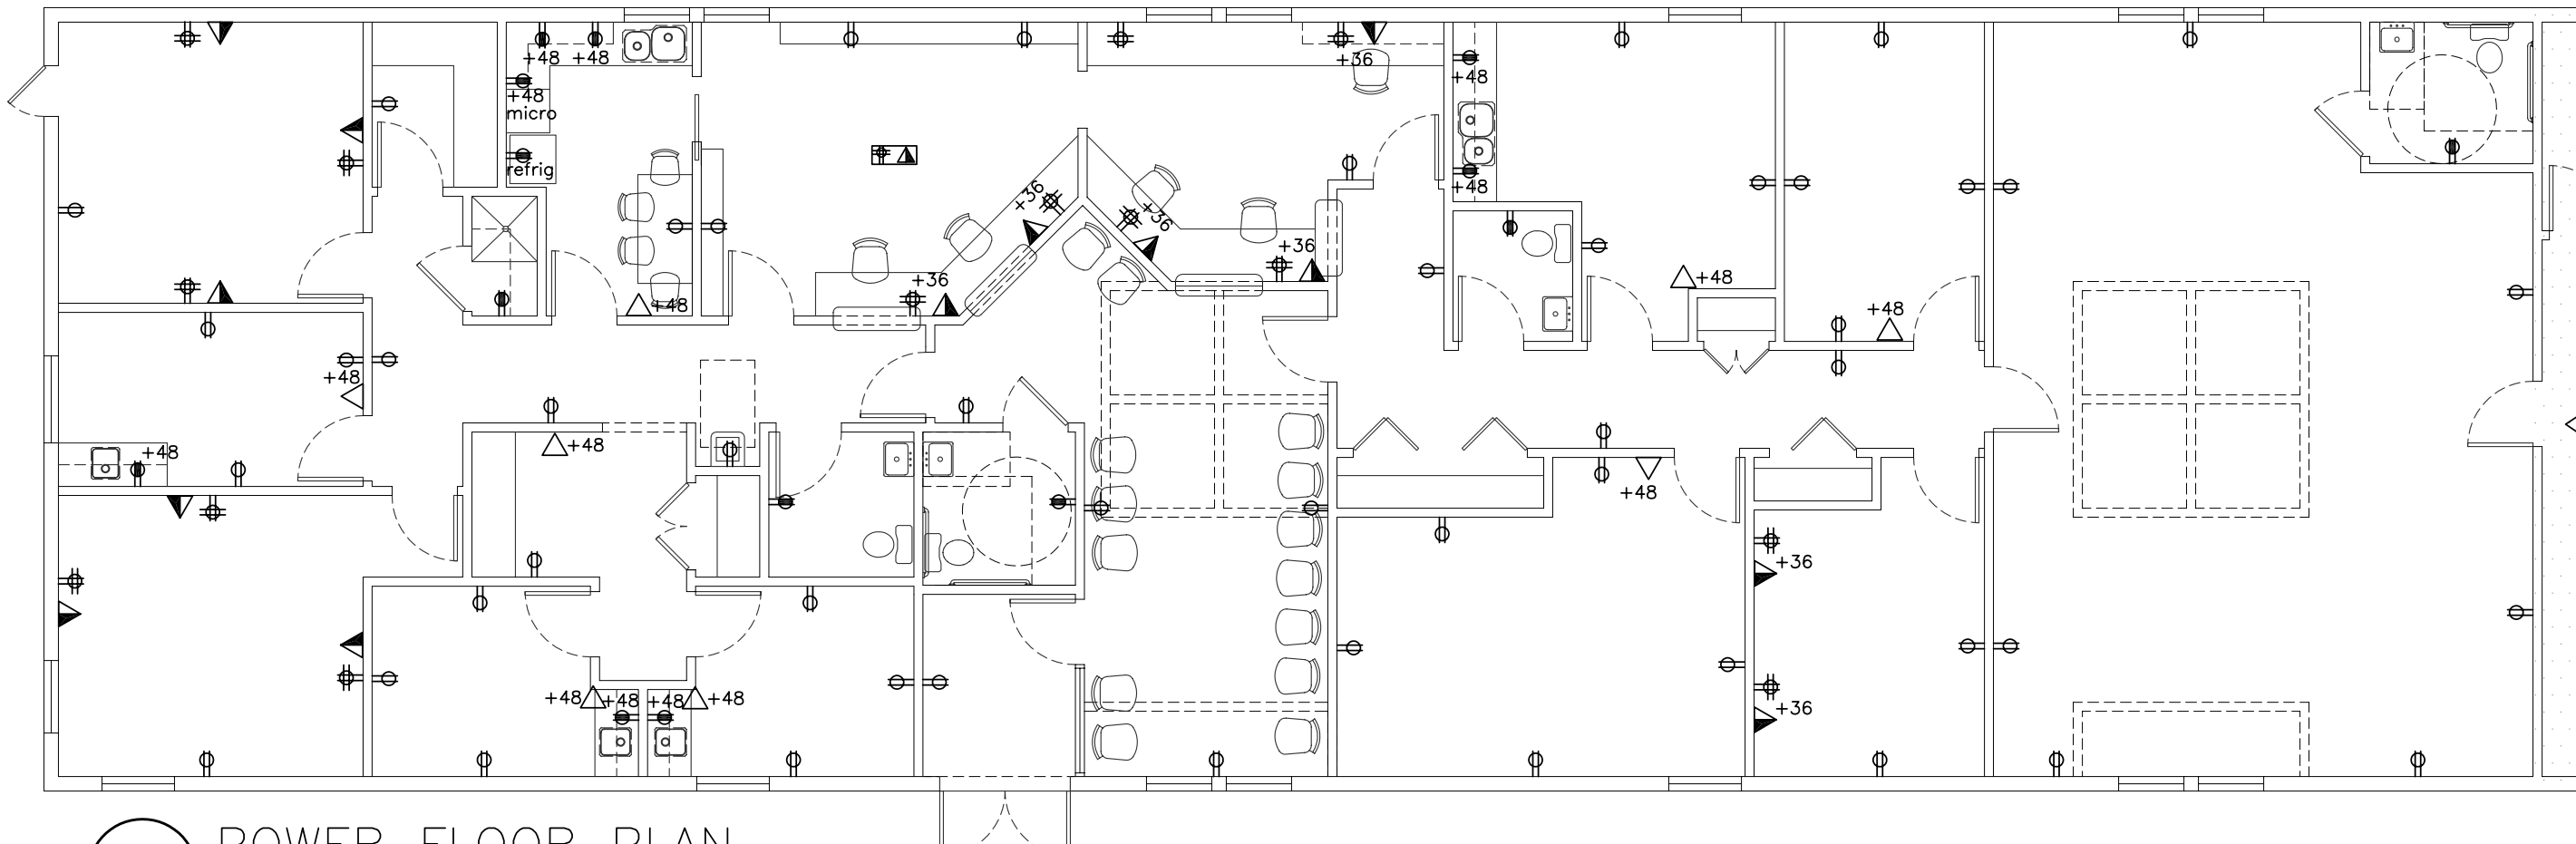

1 POWER FLOOR PLAN
SCALE: 1/8" = 1'-0"