





PRELIMINARY - NOT FOR CONSTRUCTION

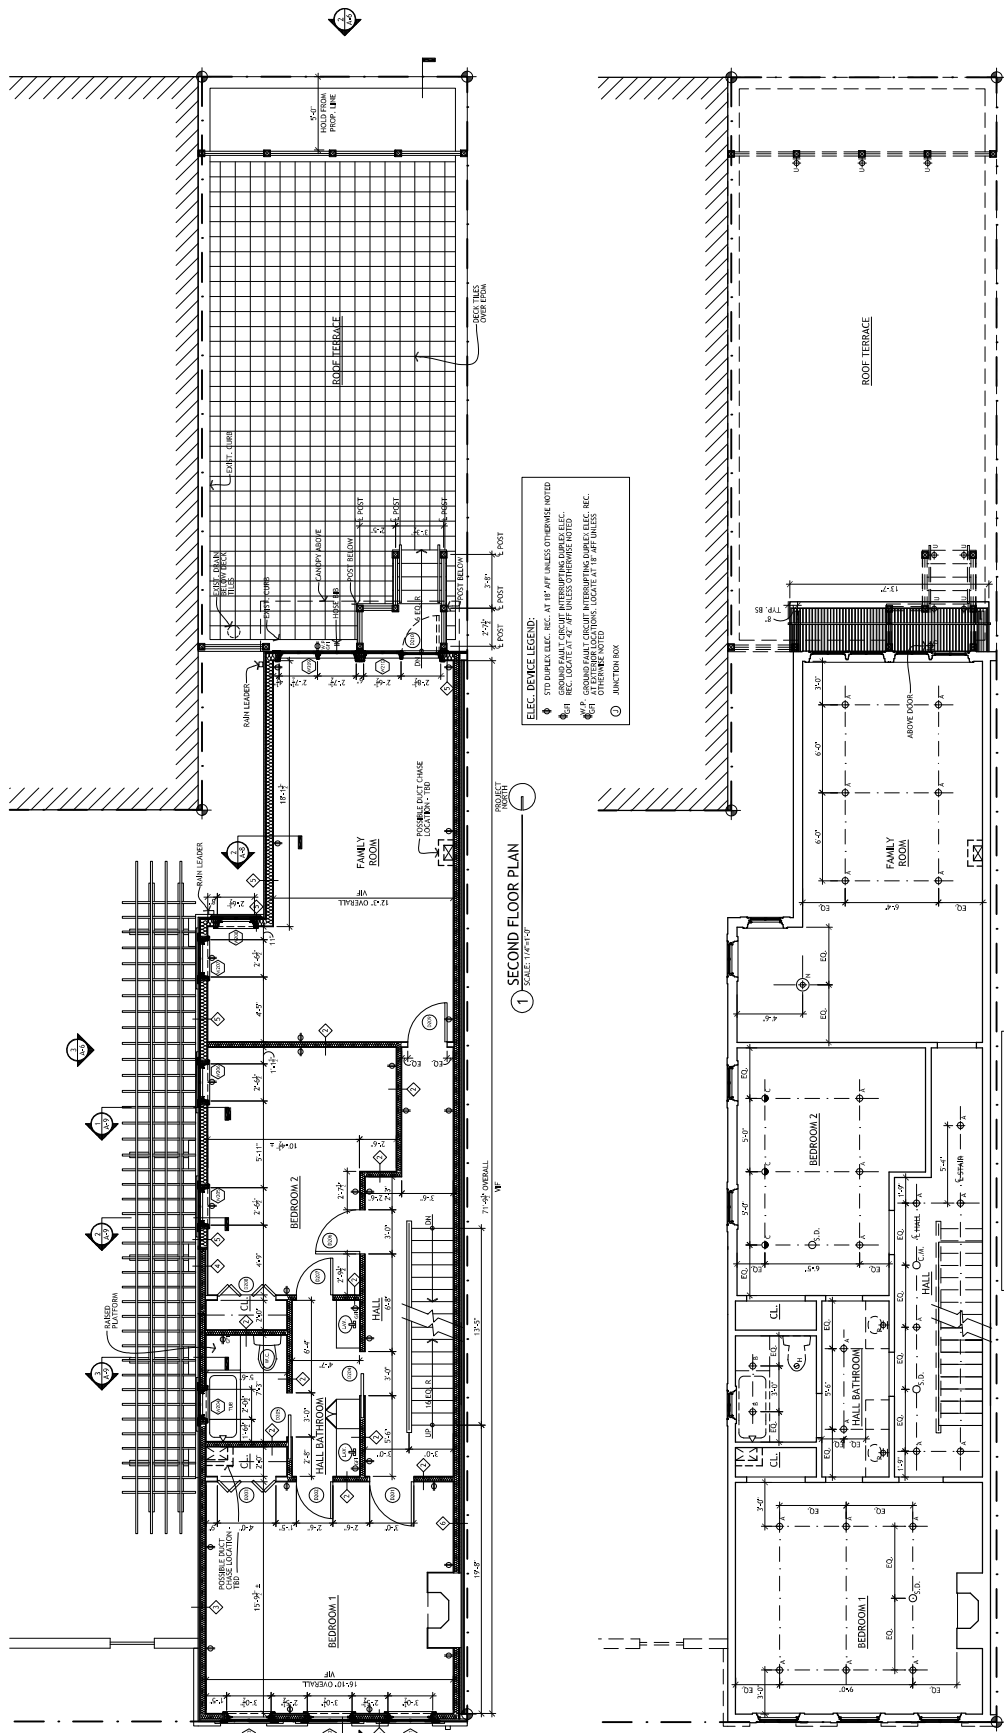

PRELIMINARY - NOT FOR CONSTRUCTION

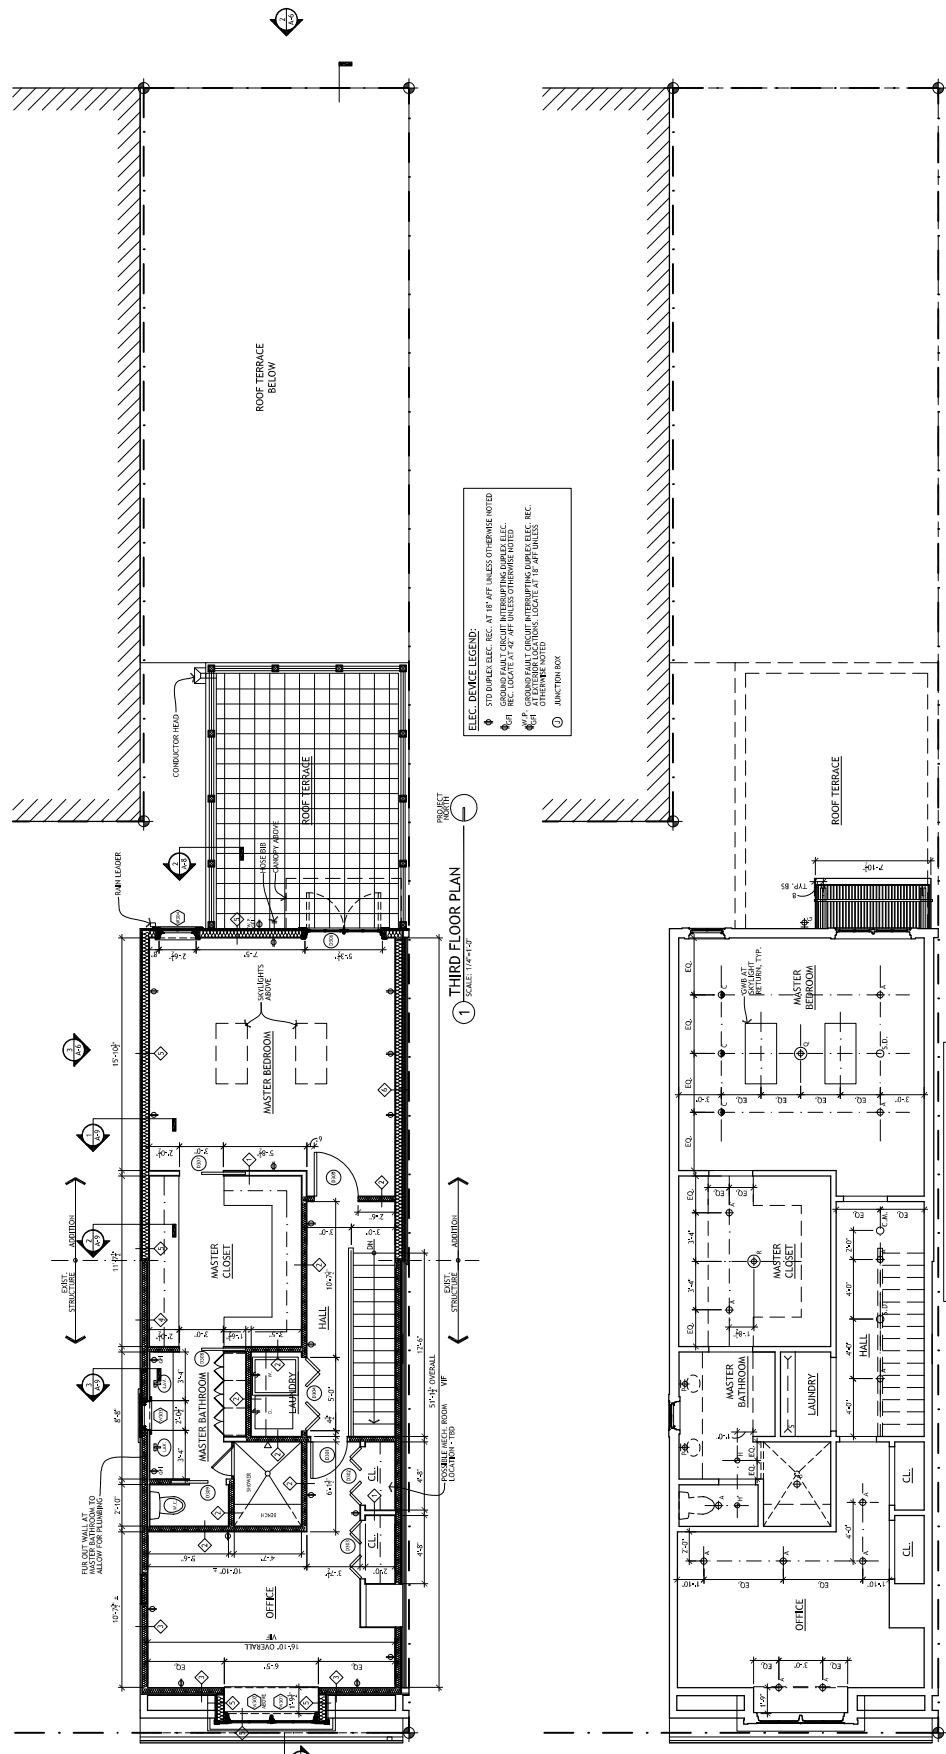

**ELEC. DEVICE LEGEND:**  
 ◆ SURFACE LIGHTING AT 4'-0" HIGHS OTHERWISE NOTED  
 ◆ RECESSED LIGHTING AT 4'-0" HIGHS OTHERWISE NOTED  
 ◆ GROUND FAULT CIRCUIT INTERRUPTING COMPLETE ELEC. REC. OTHERWISE NOTED  
 ○ JUNCTION BOX

**1 THIRD FLOOR PLAN**  
 SCALE: 1/4"=1'-0"

**2 THIRD FLOOR REFLECTED CEILING PLAN**  
 SCALE: 1/4"=1'-0"

**CEILING NOTE:**  
 ALL UNLESS OTHERWISE NOTED TO HAVE CEILING  
 TRANSLUCENT DIFFUSERS SHALL BE CEILING PANELS  
 WITH 1" SQUARE GRID. ALL UNLESS OTHERWISE NOTED  
 SHALL BE CEILING PANELS WITH 1" SQUARE  
 GRID.